




**PERSPECTIVE**  
NOT TO SCALE

**TECHNICAL DESCRIPTION OF LOT 3933-C AREA= 9,860 SQ.M.**

LINES	BEARINGS	DISTANCE
1-2	S 02° 56' E	8.17 mts.
2-3	S 51° 59' W	83.94 mts.
3-4	N 40° 41' W	112.15 mts.
4-5	N 50° 00' E	84.72 mts.
5-1	S 42° 52' E	108.66 mts.



**SITE DEVELOPMENT PLAN**  
SCALE: 1:500M.

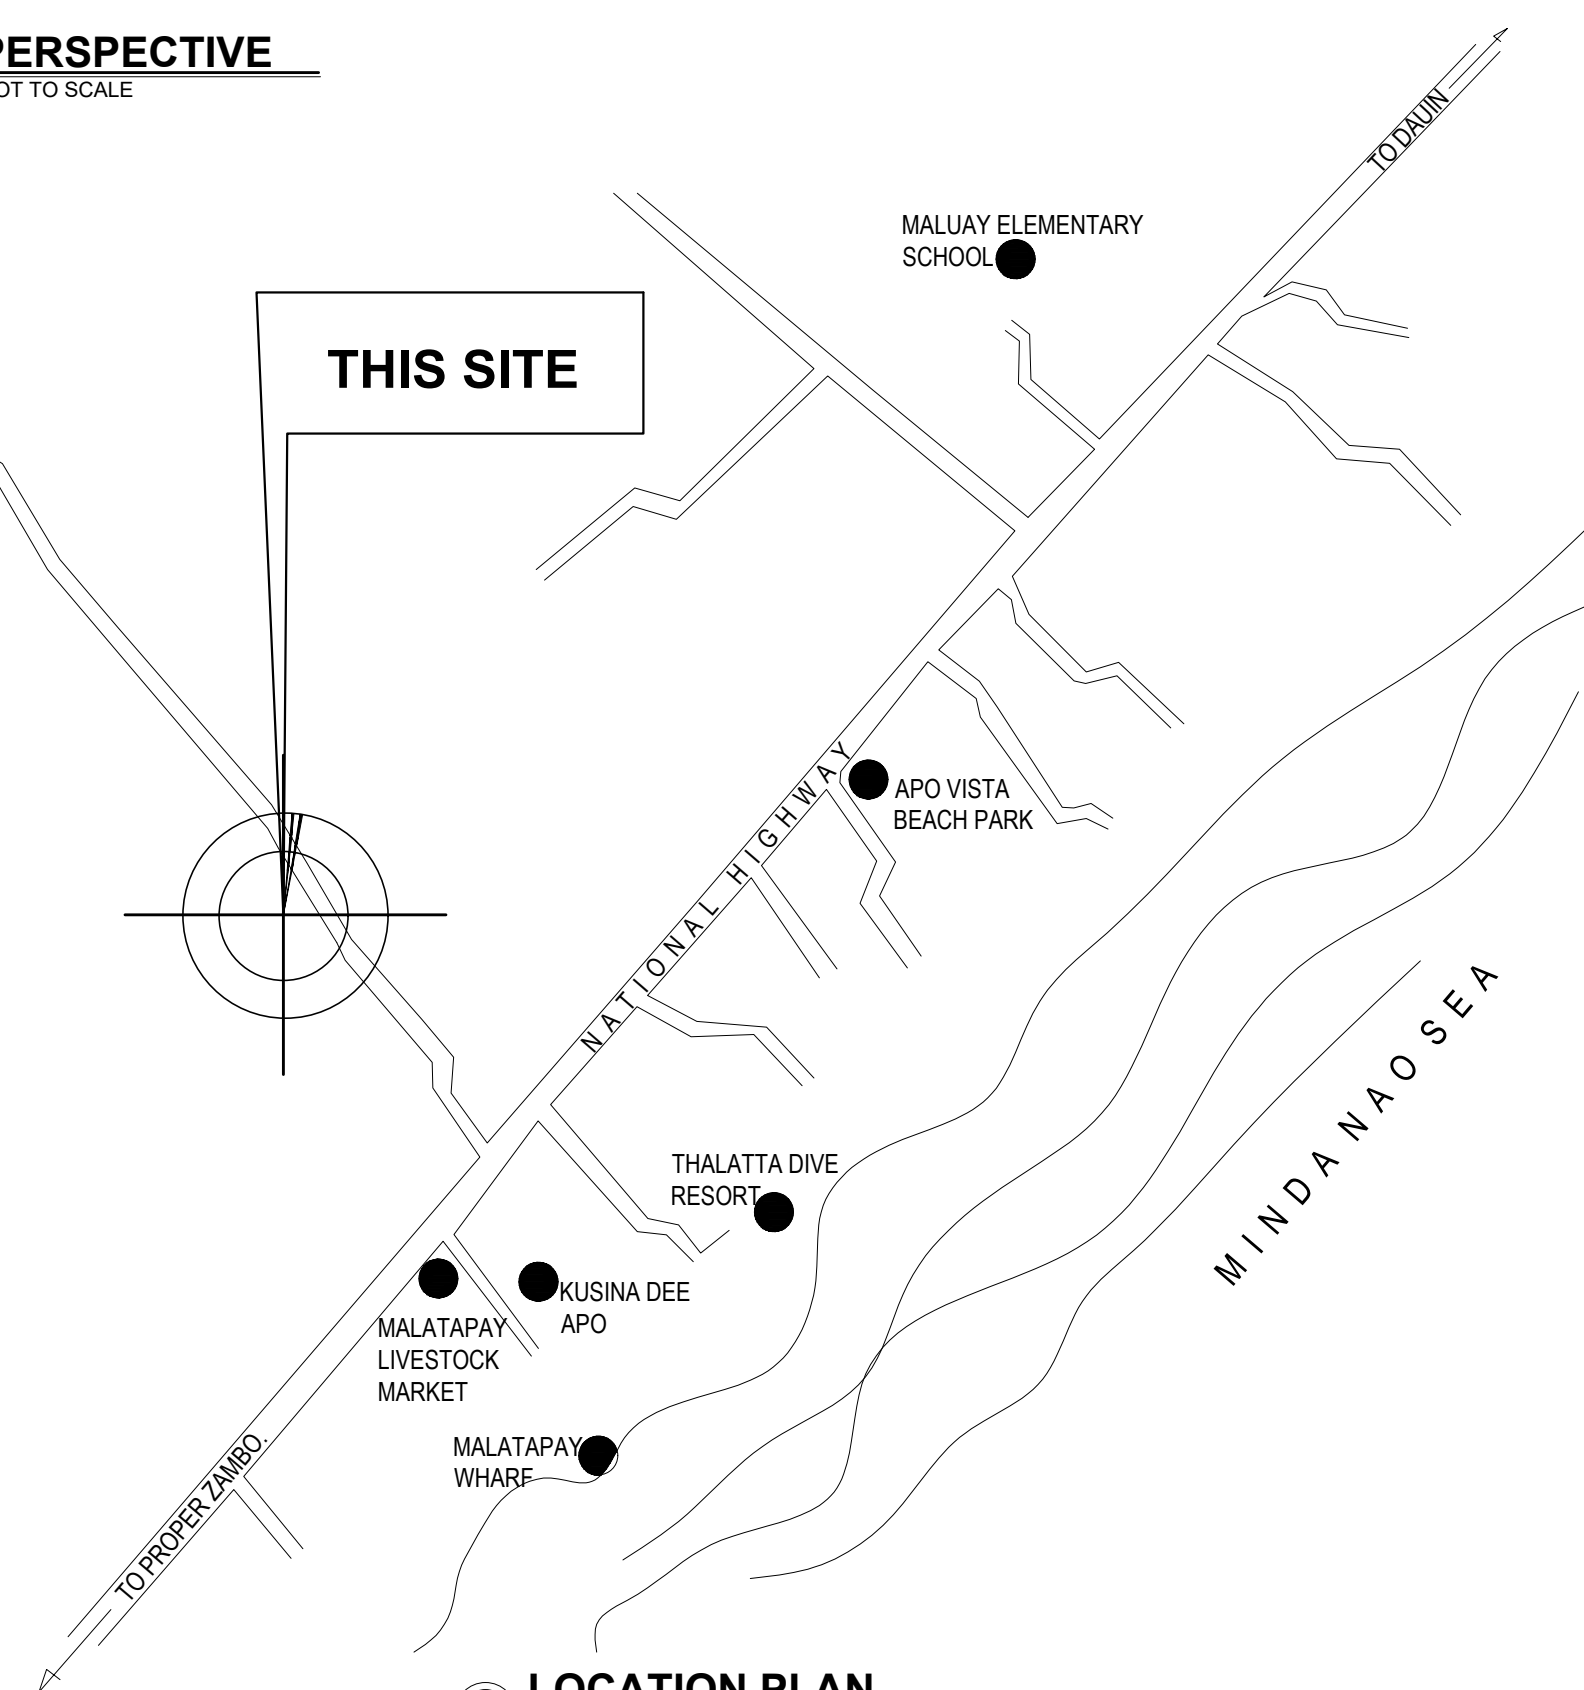

**LOCATION PLAN**  
NTS

PLANS MEET N B C REQUIREMENTS

REPUBLIC OF THE PHILIPPINES

BUILDING OFFICIAL

**OFFICE OF THE BUILDING OFFICIAL**

DATE :

MUNICIPALITY OF ZAMBOANGUITA

LAND USED & ZONING

LINE AND GRADE

DATE :

DATE :

1 (A-1) ARCHITECTURAL SHEET

- PERSPECTIVE
- SITE DEVELOPMENT PLAN
- LOCATION PLAN

STRUCTURAL

2 (A-2) ARCHITECTURAL SHEET

- FLOOR PLAN
- FRONT ELEVATION
- RIGHT-SIDE ELEVATION
- REAR ELEVATION
- LEFT-SIDE ELEVATION
- SECTION THRU 'A'
- SECTION THRU 'B'
- KITCHEN LAYOUT
- BATHROOM LAYOUT
- WINDOW SCHEDULE
- DOOR SCHEDULE

DATE :

3 (S-1) STRUCTURAL SHEET

- FOUNDATION PLAN
- ROOF BEAM PLAN
- ROOF FRAMING PLAN
- ROOF PLAN
- FULL TRUSS DETAIL 'FT'
- HALF TRUSS DETAIL 'HT'
- TRUSS TO BEAM CONNECTION DETAIL
- TYPICAL COLUMN FOOTING DETAIL
- STEEL STRUT DETAIL 'ST'
- CEILING AND SOFFIT DETAIL
- BLOW-UP GUTTER DETAIL
- TYPICAL BEAM DETAIL
- SCHEDULE OF COLUMNS
- SCHEDULE OF REINFORCED CONCRETE BEAMS
- SCHEDULE OF FOOTINGS
- JOINT TRUSS DETAIL 'JT'
- TYPICAL WALL FOOTING DETAIL

ARCHITECTURAL

DATE :

4 (E-1) ELECTRICAL SHEET

- LIGHTING LAYOUT
- POWER LAYOUT
- SINGLE LINE WIRING DIAGRAM
- SCHEDULE OF LOADS
- ELECTRICAL LEGENDS
- GENERAL NOTES AND SPECIFICATIONS

SANITARY

DATE :

5 (P-1) PLUMBING SHEET

- SANITARY LAYOUT
- WATER LAYOUT
- SANITARY SCHEMATIC DIAGRAM
- WATER SCHEMATIC DIAGRAM

ELECTRICAL

DATE :

6 (P-2) PLUMBING SHEET

- TYPICAL PIPE FITTINGS CONNECTION DETAIL
- SIMPLE-PRESSURE SYSTEM (SCHEMATIC DIAGRAM)
- GREASE TRAP DETAIL
- CATCH BASIN DETAIL
- SEPTIC TANK DETAIL
- GENERAL NOTES AND SPECIFICATIONS
- PLUMBING LEGEND

7 (M-1) MECHANICAL SHEET

- AIRCON LAYOUT
- SCHEDULE OF MACHINERIES
- WALL MOUNTED ACU DETAIL
- LEGENDS
- GENERAL NOTES

ENRO

REVIEWED BY :

DATE :

DATE :

FIRE DEPARTMENT

PROCESSED BY :

DATE :

DATE :

ARCHITECT / CIVIL ENGINEER	PRC NO. :	SEAL	PROJECT TITLE:	APPROVE AS PER PLAN	DESIGNED BY: ALRIN G. NODADO, DPX	CONTENTS	REVISIONS	SHEET NO.
	T.I.N. NO. :		A PROPOSED ONE STOREY RESIDENTIAL BUILDING	GLENN CHOKOLA	CADD BY: CLIFFORD A. ALABATA	AS SHOWN		<b>A-1</b>
	PTR NO. :			OWNER	SCALE: AS INDICATED			OF 6
	DATE ISSUED :				CHECKED BY: REY KATADA			ARCHITECTURAL
ADDRESS:	ADDRESS:		LOCATION: MALUAY, ZAMBOANGUITA, NEGROS ORIENTAL	ADDRESS: MALUAY, ZAMBOANGUITA, NEGROS ORIENTAL	DATE:			